


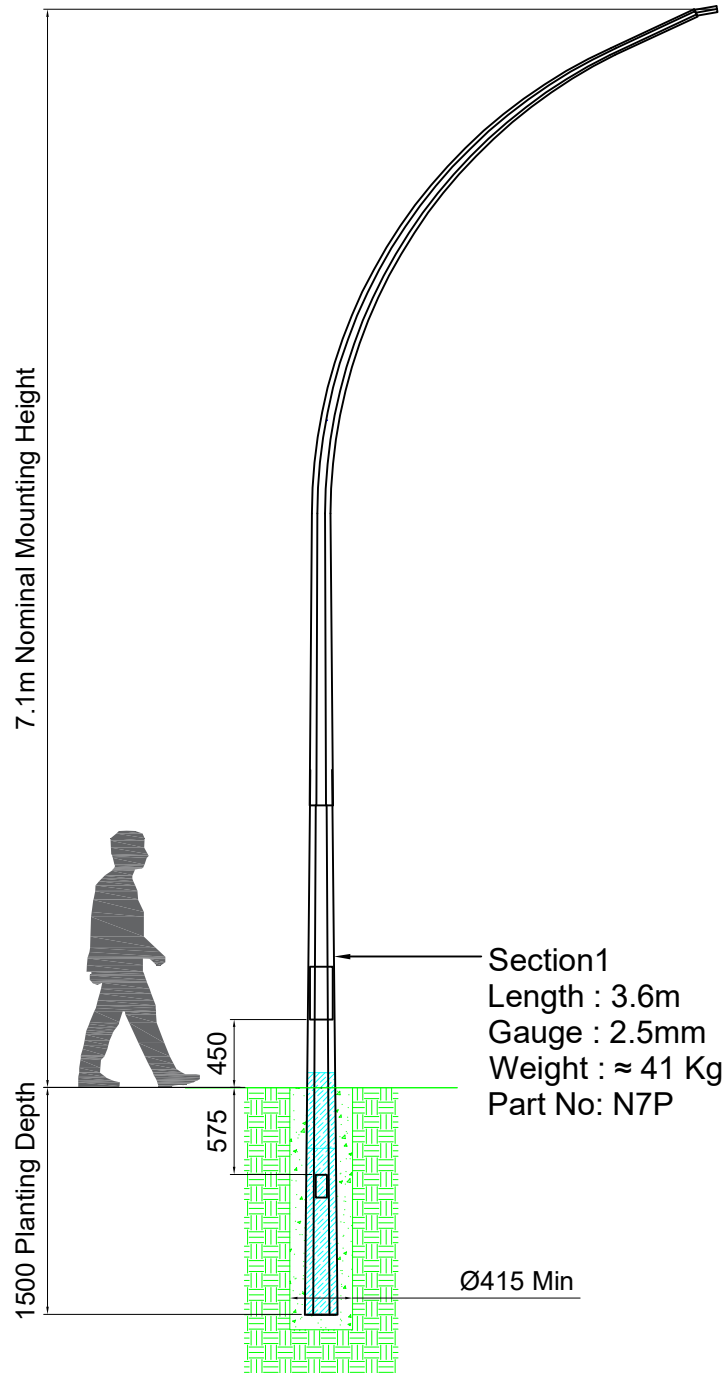

Product: 7.1m Octagonal Elliptical Streetlight Pole - Ground Planted

Standards: Complies with M26

Drawing No. OT-SLE-071-P-1

Drawing Scale NTS

Drawn By DDC

Date 23/5/2018

Revised By CMW

Revised Date 21/6/2024

Approved By WY

Pole Design

: AS/NZS 4676 / AS/NZS 1170.2:2021

Material

: EN 12767 Class 0 / BS 4360 / BS EN 10025

Welding(Electric Arc)

: AS 1554

Galvanising

: AS/NZS 4680

Finishing Types

: Hot Dip Galvanized

: Protective Epoxy Paint(Sigmashield) to NZTA

and ATCop Stds.From 100–200mm above

ground level to section bottom.

: Paint – Standard 10 year – by request

: Foundation Design and PS1 by request

Foundation Design

*This drawing and the information contained herein, is the sole property of Steelgal NZ Limited and may not be used without consent from Steelgal NZ limited.