


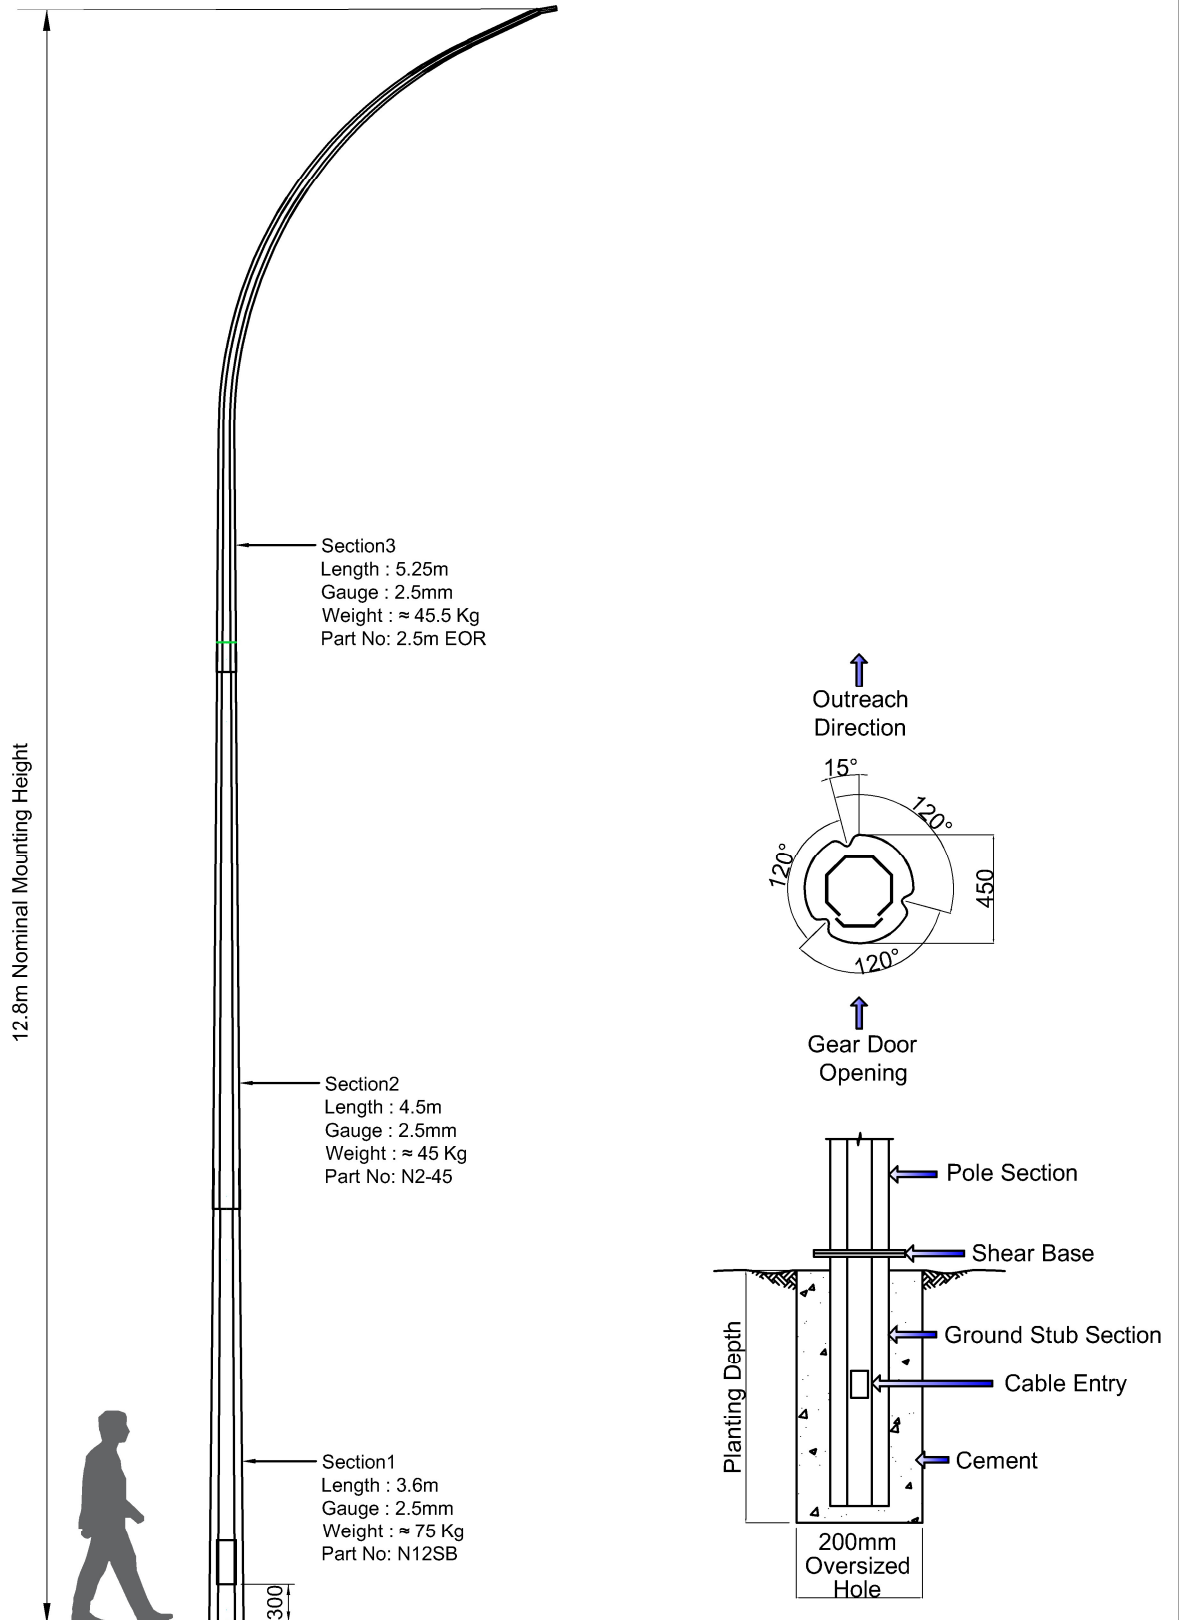

Product: 12.8m Octagonal Elliptical Streetlight Pole - Shear Base

Standards: Complies with M26

Drawing No. OT-SLE-128-S-1

Drawing Scale NTS

Drawn By DDC

Date 1/6/2018

Revised By CMW

Revised Date 29/2/2024

Approved By WY

Pole Design

Material

Welding(Electric Arc)

Galvanising

Finishing Types

: AS/NZS 4676 / AS/NZS 1170.2: 2021

: EN 12767 Class 0 / BS 4360 / BS EN 10025

: AS 1554

: AS/NZS 4680

: Hot Dip Galvanized

: Protective Epoxy Paint(Sigmashield) to NZTA and ATCop Stds.From 100–200mm above ground level to section bottom.

: Paint – Standard 10 year – by request

: Foundation Design and PS1 by request

Foundation Design

*This drawing and the information contained herein, is the sole property of Steelgal NZ Limited and may not be used without consent from Steelgal NZ limited.