


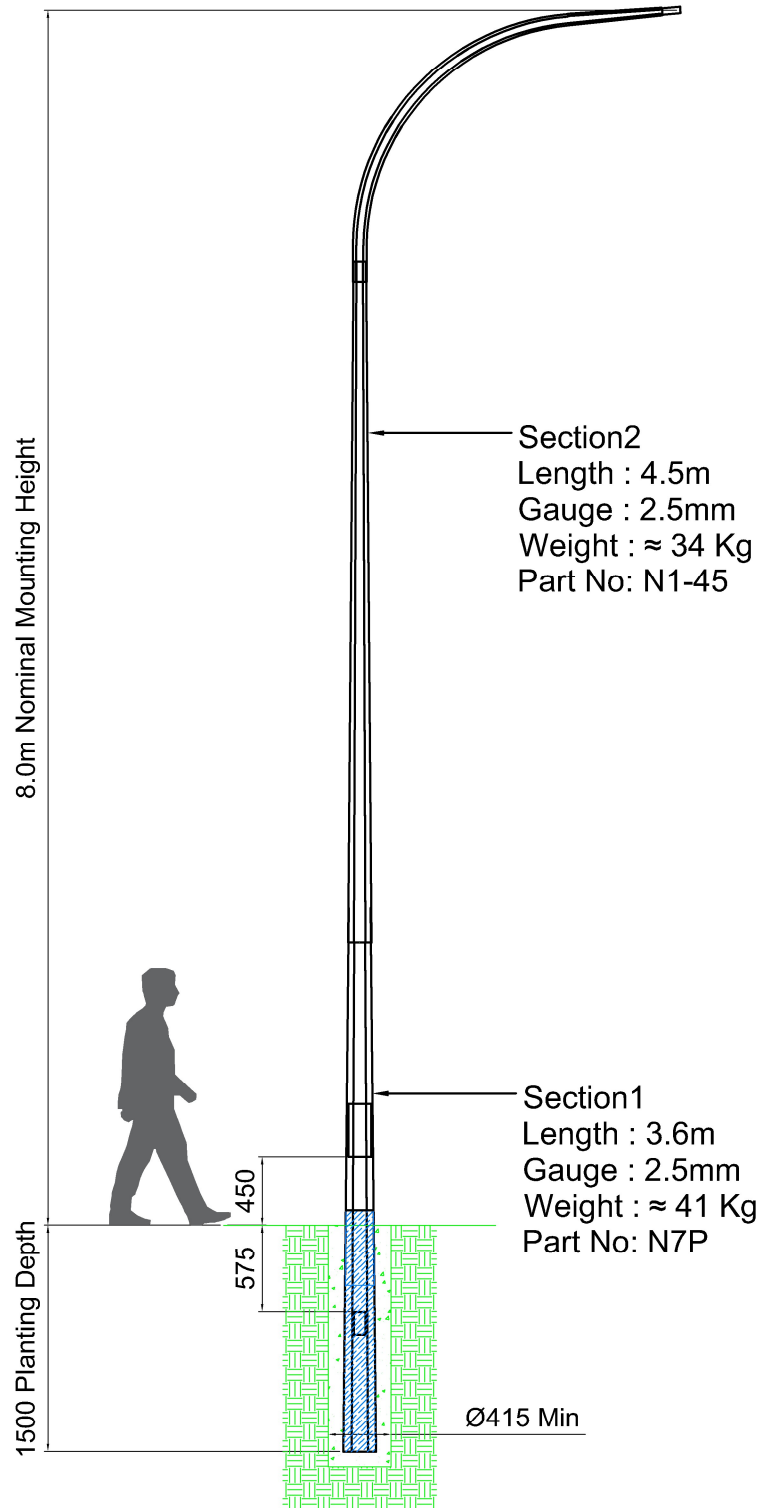

Product: 8.0m Octagonal Streetlight Pole - Ground Planted

Drawing No. OT-SLS-080-P-1
Drawing Scale NTS
Drawn By DDC
Date 23/5/2018
Revised By CMW
Revised Date 15/5/2024
Approved By WY

Standards: Complies with M26

Pole Design : AS/NZS 4676 / AS/NZS 1170.2: 2021
Material : EN 12767 Class 0 / BS 4360 / BS EN 10025
Welding(Electric Arc) : AS 1554
Galvanising : AS/NZS 4680
Finishing Types : Hot Dip Galvanized
: Protective Epoxy Paint(Sigmashield) to NZTA
and ATCop Stds.From 100–200mm above
ground level to section bottom.
: Paint – Standard 10 year – by request
: Foundation Design and PS1 by request

*This drawing and the information contained herein, is the sole property of Steelgal NZ Limited and may not be used without consent from Steelgal NZ limited.