



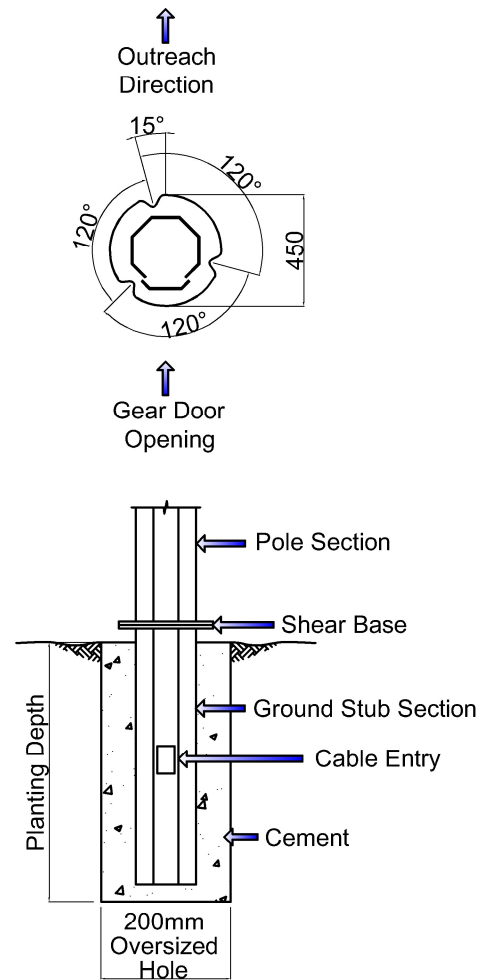

STEELGAL
NZ LIMITED

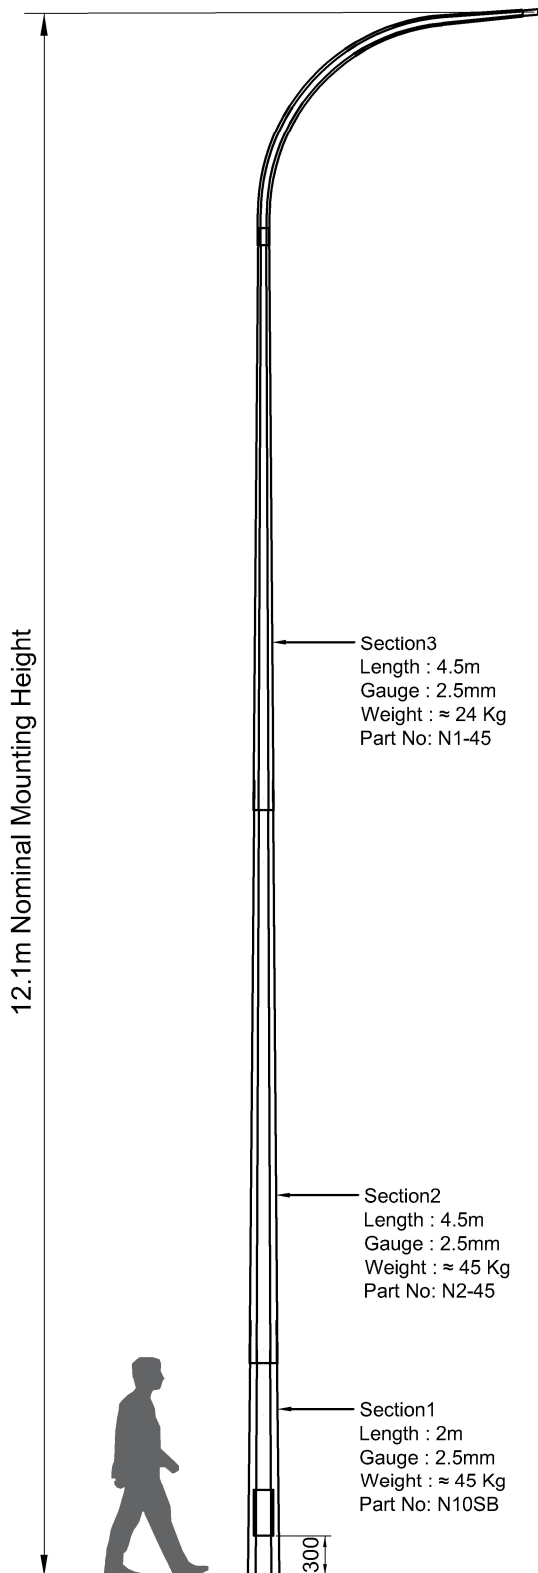

Product: 12.1m Octagonal Streetlight Pole - Shear Base

Standards: Complies with M26

Drawing No. OT-SLS-121-S-1
Drawing Scale NTS
Drawn By DDC
Date 1/6/2018
Revised By CMW
Revised Date 29/2/2024
Approved By WY

Pole Design : AS/NZS 4676 / AS/NZS 1170.2:2021
Material : EN 12767 Class 0 / BS 4360 / BS EN 10025
Welding(Electric Arc): AS 1554
Galvanising : AS/NZS 4680
Finishing Types : Hot Dip Galvanized
: Protective Epoxy Paint(Sigmashield) to NZTA
and ATCop Stds.From 100–200mm above
ground level to section bottom.
: Paint – Standard 10 year – by request
: Foundation Design and PS1 by request

*This drawing and the information contained herein, is the sole property of Steelgal NZ Limited and may not be used without consent from Steelgal NZ limited.