





STEELGAL
NZ LIMITED

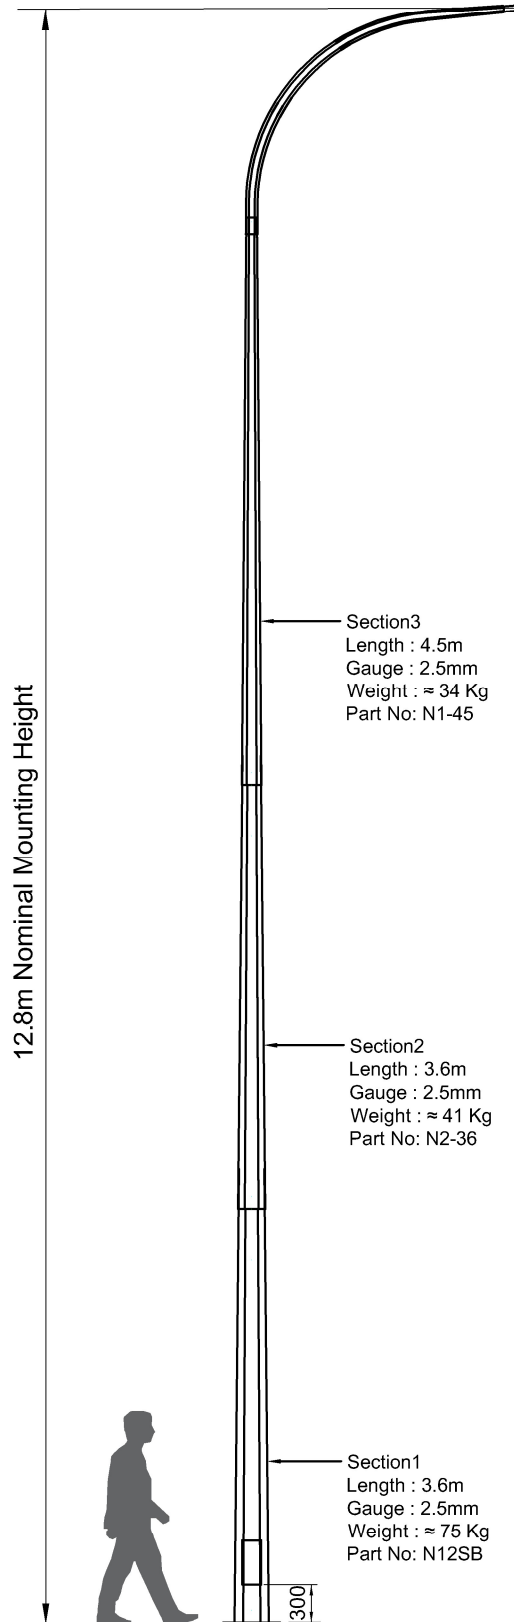

Section3
Length : 4.5m
Gauge : 2.5mm
Weight : ≈ 34 Kg
Part No: N1-45

Section2
Length : 3.6m
Gauge : 2.5mm
Weight : ≈ 41 Kg
Part No: N2-36

Section1
Length : 3.6m
Gauge : 2.5mm
Weight : ≈ 75 Kg
Part No: N12SB

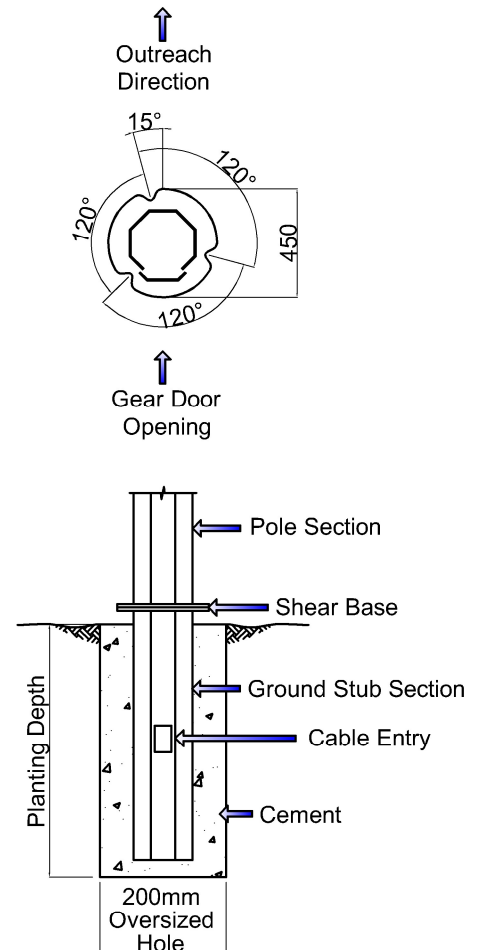

Product: 12.8m Octagonal Streetlight Pole - Shear Base

Standards: Complies with M26

Drawing No. OT-SLS-128-S-1

Drawing Scale NTS

Drawn By DDC

Date 1/6/2018

Revised By CMW

Revised Date 29/2/2024

Approved By WY

Pole Design

Material

Welding(Electric Arc)

Galvanising

Finishing Types

: AS/NZS 4676 / AS/NZS 1170.2: 2021

: EN 12767 Class 0 / BS 4360 / BS EN 10025

: AS 1554

: AS/NZS 4680

: Hot Dip Galvanized

: Protective Epoxy Paint(Sigmashield) to NZTA
and ATCop Stds.From 100–200mm above
ground level to section bottom.

: Paint – Standard 10 year – by request

: Foundation Design and PS1 by request

Foundation Design

*This drawing and the information contained herein, is the sole property of Steelgal NZ Limited and may not be used without consent from Steelgal NZ limited.